


23004 SPRING LAKE PUMP STATION

LEGEND	SYMBOL
Description	
Building Footprint	[Solid Grey Area]
Centerline	[Dashed Line]
Comm Line	[Line with 'c' markers]
Control Points	[Triangle]
Demo	[Dashed line with 'DEMO' text]
Do not Demo	[Dashed line with 'NO_DEMO' text]
Easements	[Dashed line]
Edge of Pavement (EOP)	[Dashed line]
Existing Asphalt	[Stippled Pattern]
Existing Asphalt Pattern	[Cross-hatched Pattern]
Existing Concrete	[Stippled Pattern]
Existing Concrete Pattern	[Cross-hatched Pattern]
Fences	[Square]
Fiberoptic, TV or Telephone Structures	[Square with 'C']
Gas Distribution Main	[Line with 'G']
Gas Distribution Service	[Line with 'S']
Gas Valve	[Circle with 'V']
Guy Anchor	[Circle with 'A']
Junction Box	[Square with 'J']
Miscellaneous Points	[X]
Overhead Wire	[Line with 'O']
Power Structure	[Square with 'E']
Proposed Asphalt	[Stippled Pattern]
Proposed Asphalt Pattern	[Cross-hatched Pattern]
Proposed Concrete	[Stippled Pattern]
Proposed Concrete Pattern	[Cross-hatched Pattern]
Proposed Sawcut or Mill Extent	[Dashed line]
Sewer Cleanout	[Circle with 'C']
Sewer Gravity Main	[Line with 'S']
Sewer Lateral	[Line with 'L']
Sewer Manhole	[Circle with 'M']
Sewer Pressurized Main	[Line with 'P']
Sewer Structures	[Square]
Sign	[Circle]
Signal Poles, Power Pole	[Circle with 'P']
Storm Catch Basin	[Square]
Storm Culvert	[Line with 'C']
Storm Ditch	[Dashed line]
Storm Gravity Main	[Line with 'S']
Storm Sewer NEW: piping	[Line with 'S']
Storm Sewer NEW: structs	[Square]
Storm/Drainage Manhole	[Circle with 'M']
Taxlot	[Dashed line]
Test Pits/Bore holes	[Circle]
Topo-Bench Mark	[Triangle]
Topo-major contours, NEW	[Dashed line]
Topo-major gridlines	[Dashed line]
Topo-minor contours, NEW	[Dashed line]
Vege-Shrub	[Circle with 'S']
Vege-Tree Deciduous	[Circle with 'D']
Vege-Tree Evergreen	[Circle with 'E']
Water Fire Hydrant	[Circle with 'H']
Water Meter	[Circle with 'M']
Water Pressurized Main	[Line with 'P']
Water Service Lateral	[Line with 'L']
Water Valve	[Circle with 'V']
Water-New Pipe	[Line with 'P']
Water-Pipe Restraint	[Line with 'R']

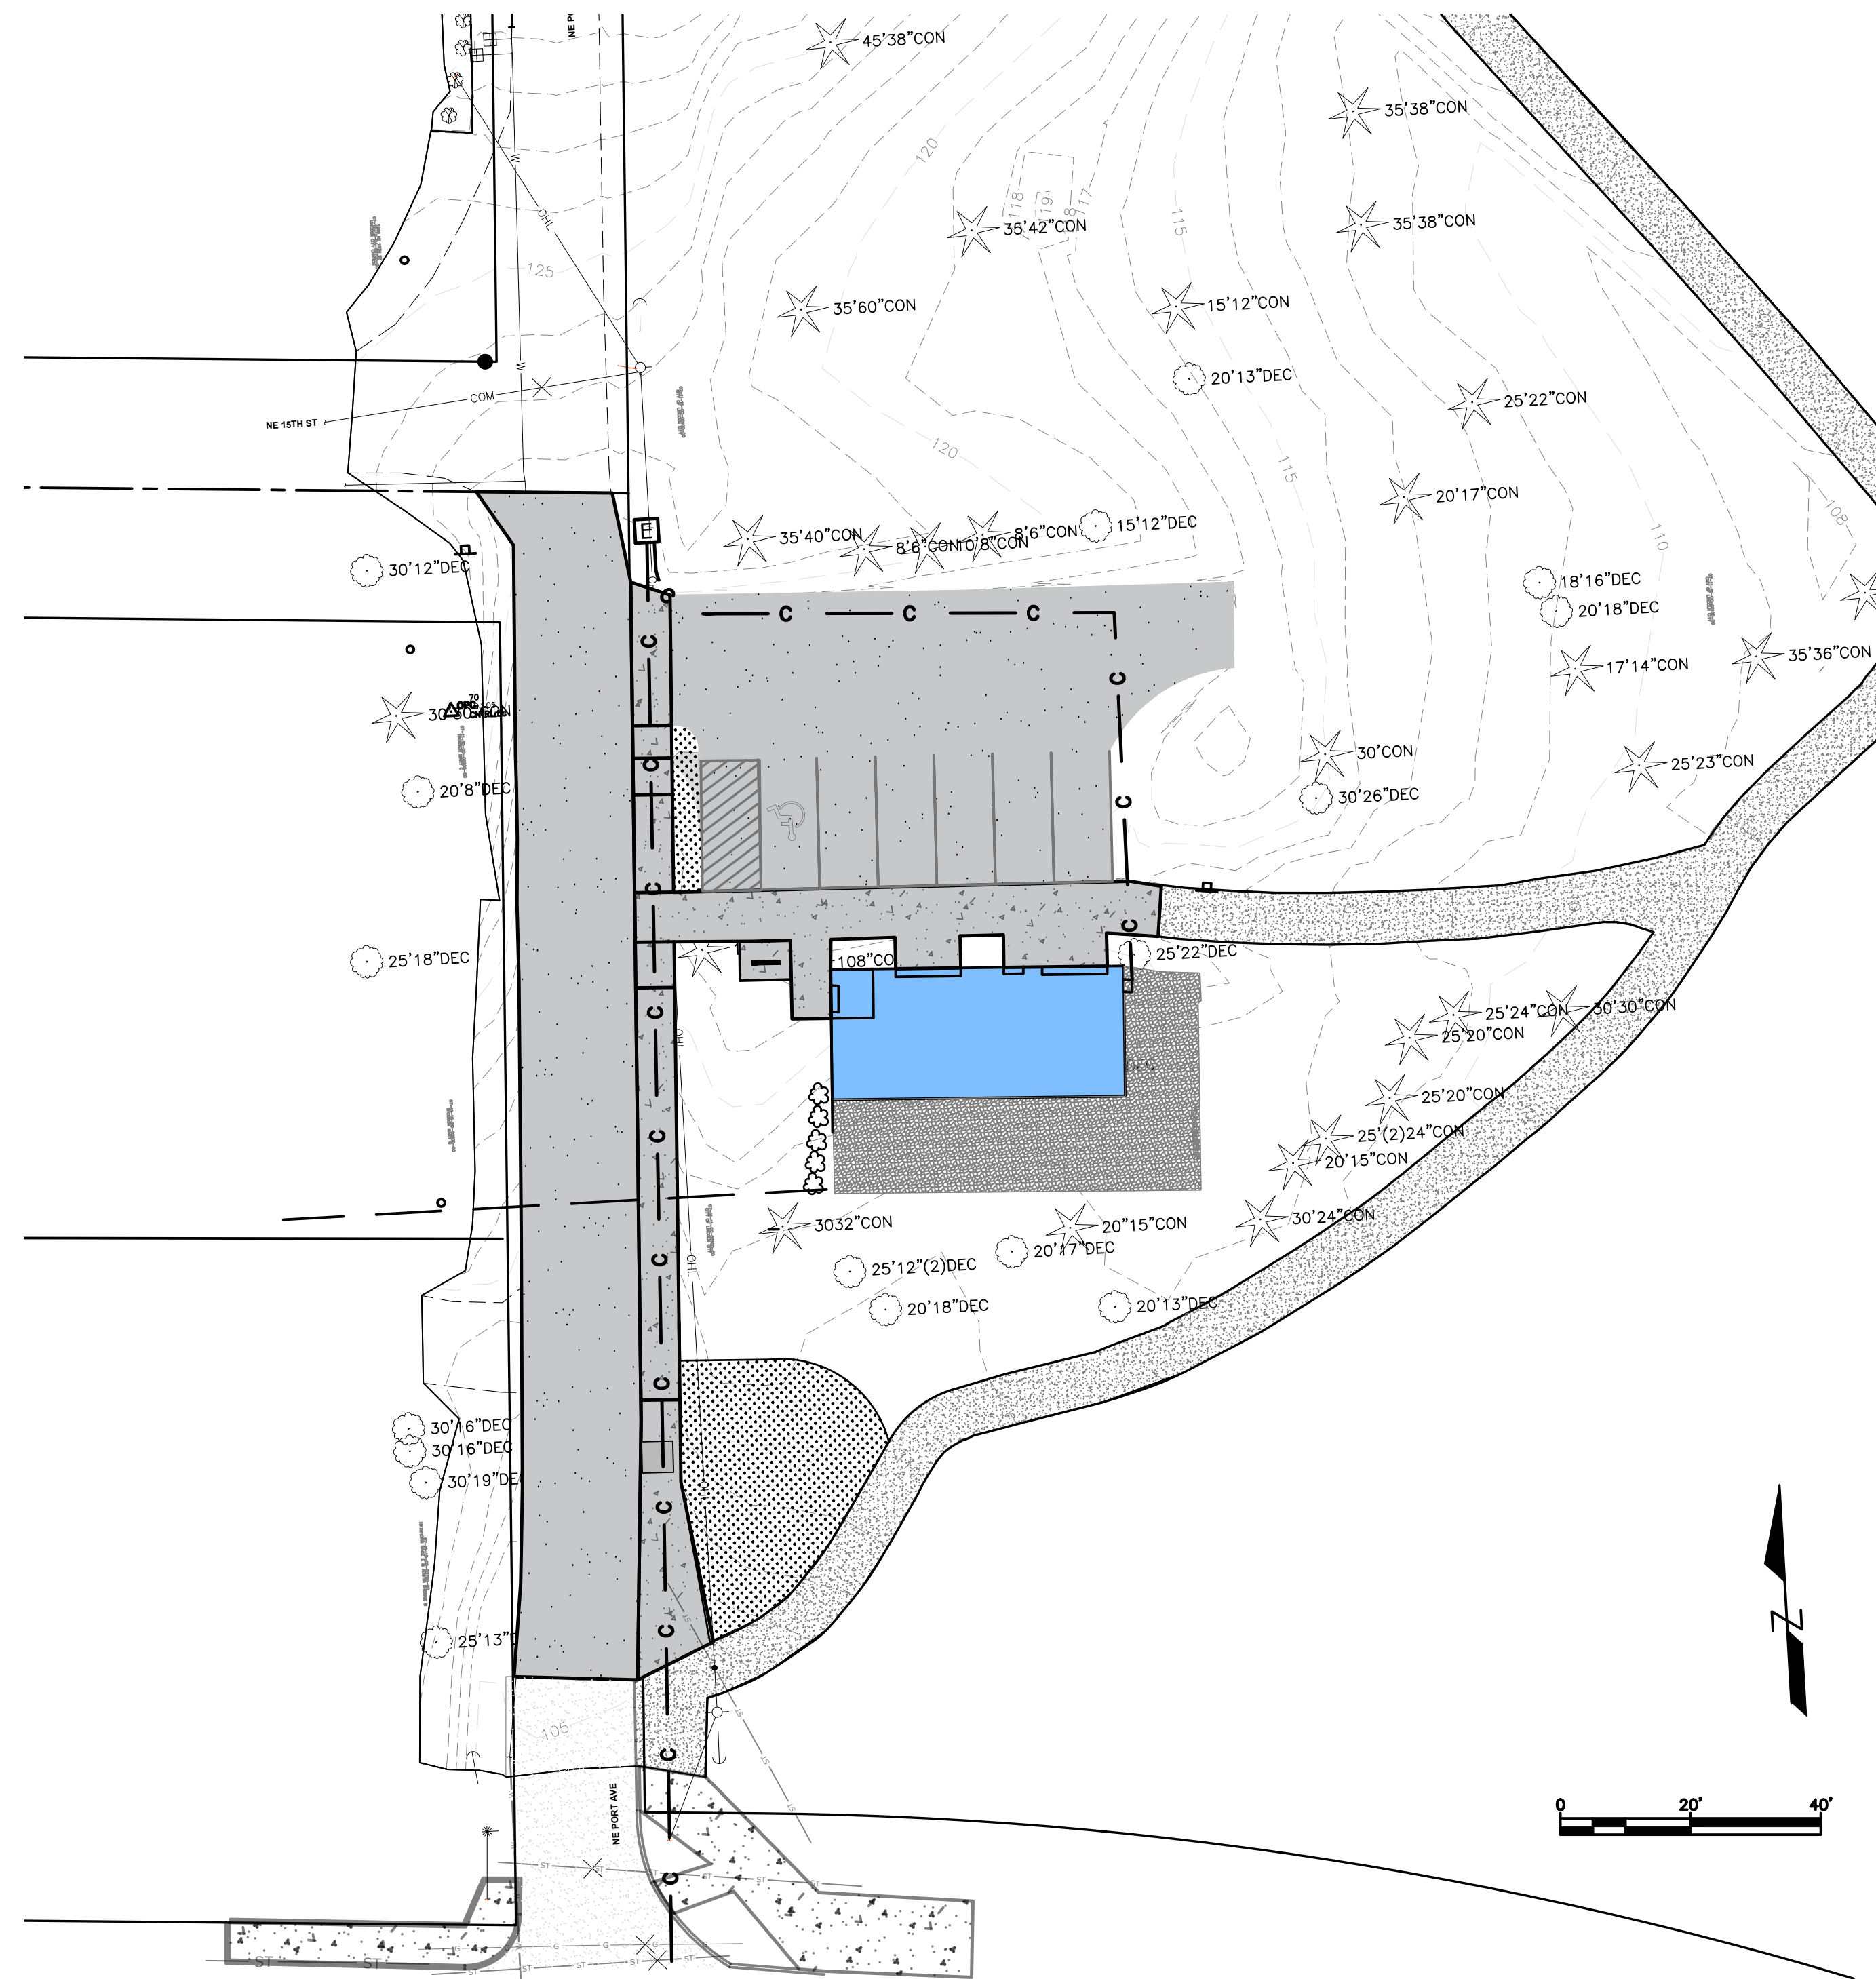

General Notes

OWNER: LINCOLN CITY
 CITY OF LINCOLN CITY
 801 SW HIGHWAY 101
 PO BOX 50
 LINCOLN CITY, OREGON 97367

CONTACT: TERRY CHAMBERLIN, P.E.
 PHONE: 541.996.1292


CALL BEFORE YOU DIG!
 1-800-332-2344



ATTENTION:
 OREGON LAW REQUIRES YOU TO FOLLOW RULES ADOPTED BY THE OREGON UTILITY NOTIFICATION CENTER. THESE RULES ARE SET FORTH IN OAR 850.000-0000 THROUGH OAR 850.0000. YOU MAY OBTAIN COPIES OF THE RULES BY CALLING THE CENTER. NOTE: THE TELEPHONE NUMBER FOR THE OREGON UTILITY NOTIFICATION CENTER IS (800) 232-2344.



No.	Revision/Issue	Date

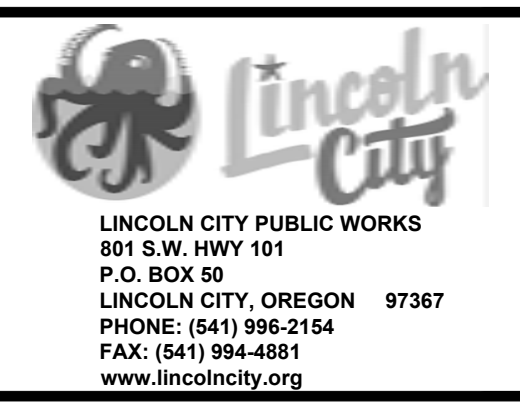

Project Name and Sheet Name
Spring Lake Pump Station
 Cover Sheet

DESIGNED BY: ####
 PREPARED BY: ####

Project No.: 23004	Sheet No.:
Date: 2/20/2025	1 OF 5
Scale: AS SHOWN IF LESS THAN FULL SIZE, NTS	




Base Drawing.dwg

1/23/2025

23004 SPRING LAKE PUMP STATION

Existing Conditions

Proposed Site Development & Improvements

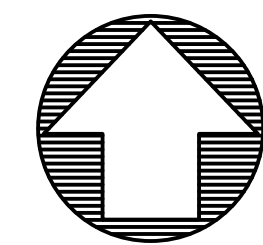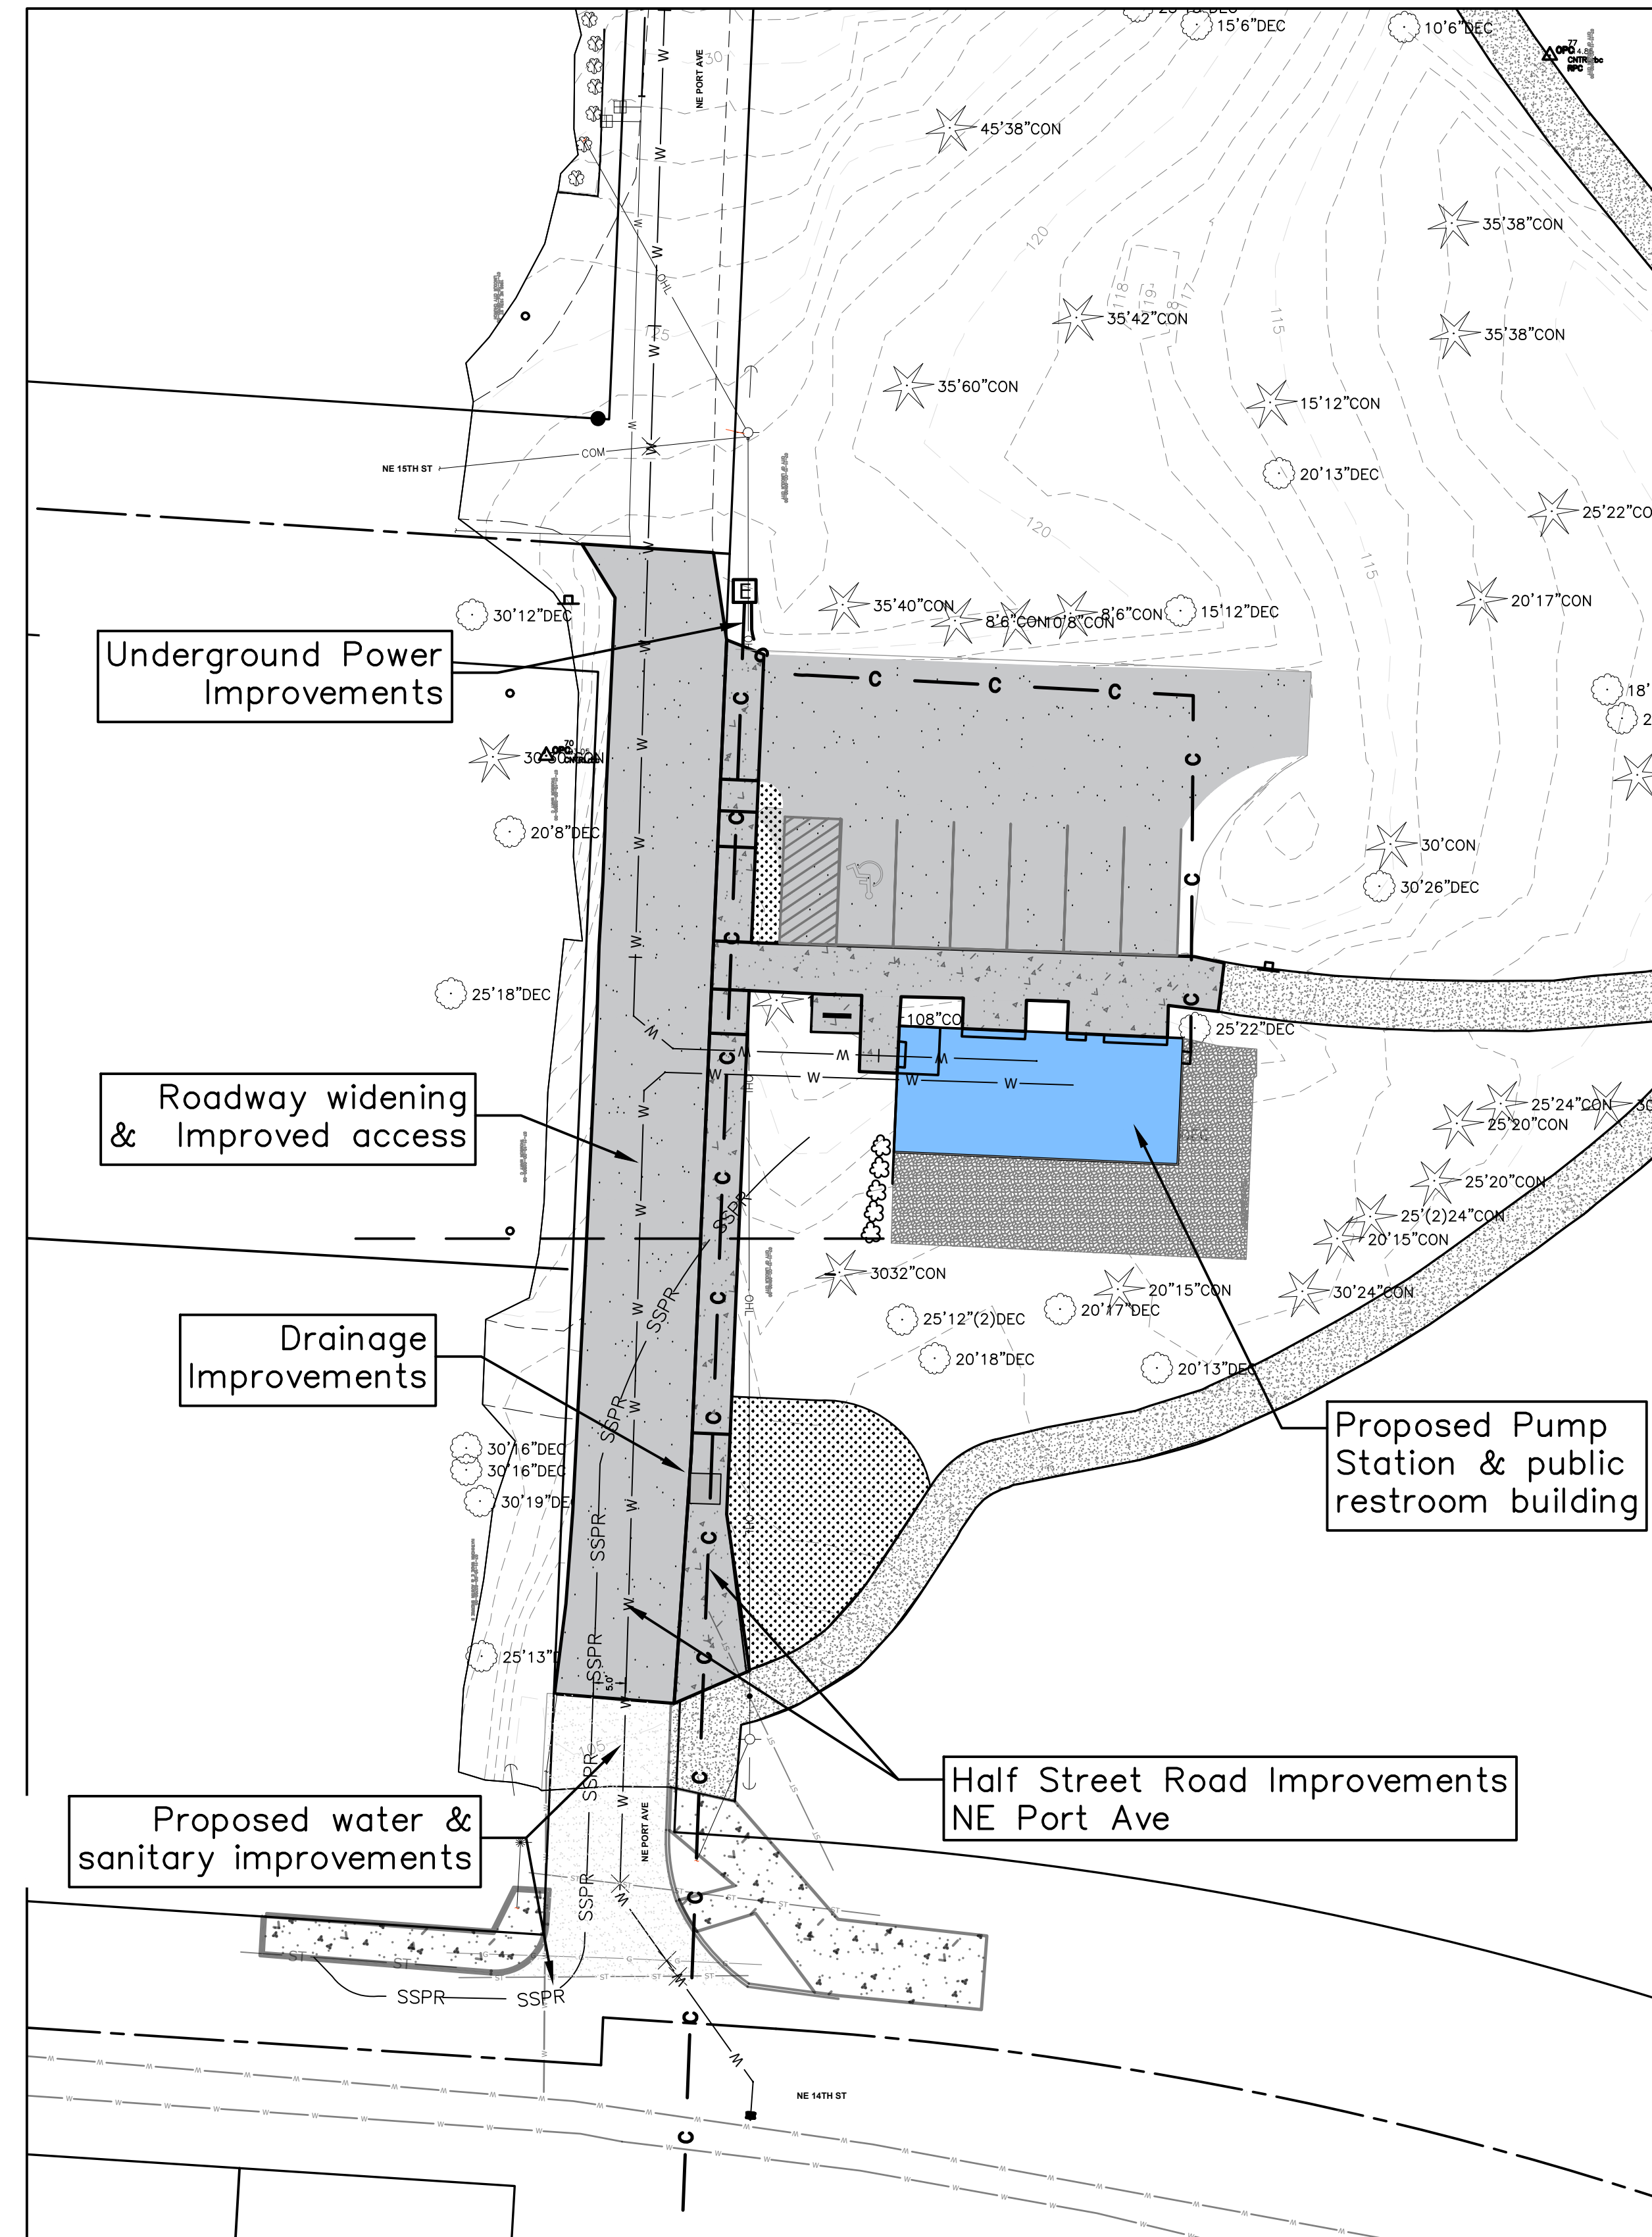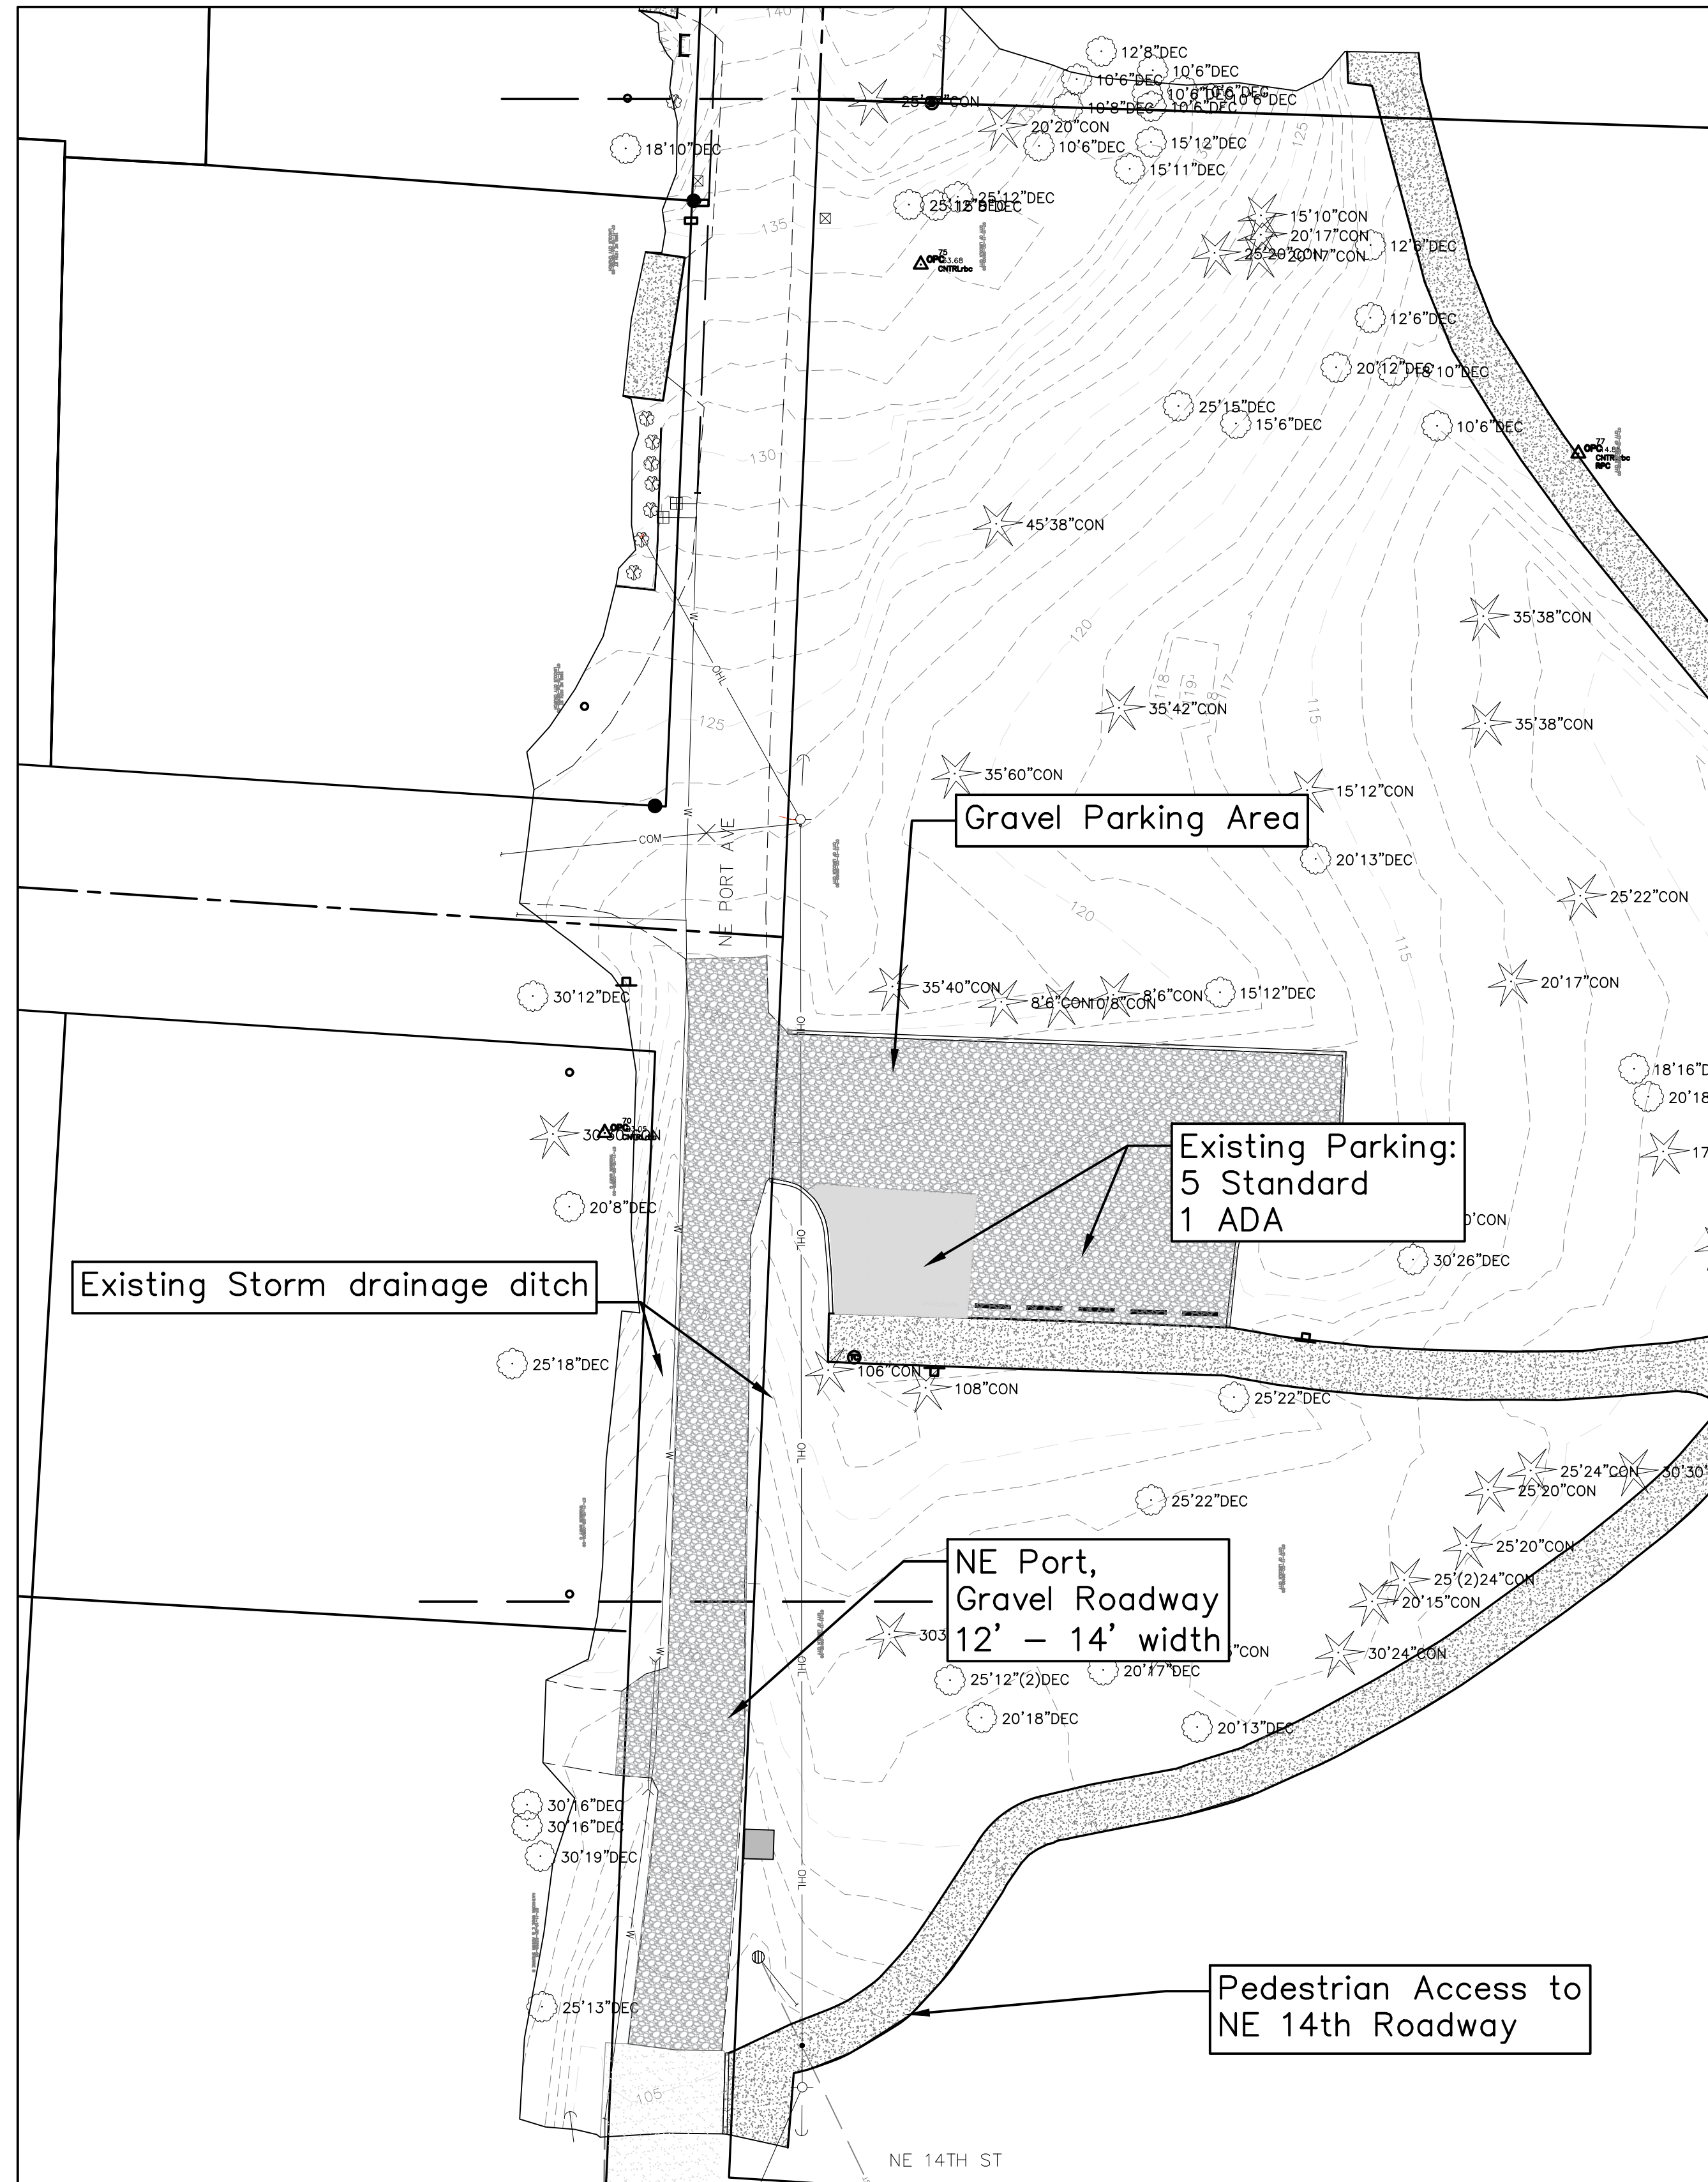


Scale: 1" = 20'

General Notes

OWNER: LINCOLN CITY
 CITY OF LINCOLN CITY
 801 SW HIGHWAY 101
 P.O. BOX 50
 LINCOLN CITY, OREGON 97367
 CONTACT: TERRY CHAMBERLIN, P.E.
 PHONE: 541.996.1292




No.	Revision/Issue	Date

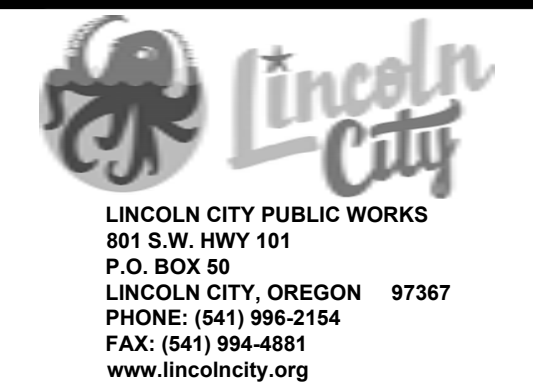

Project Name and Sheet Name
Spring Lake Pump Station
 Existing Conditions & Site Plan
 DESIGNED BY: ##
 PREPARED BY: ##


Project No.: 23004	Sheet No. 2 OF 5
Date: 2/20/2025	
Scale: 1" = 20' IF LESS THAN FULL SIZE, NTS	

23004 SPRING LAKE PUMP STATION

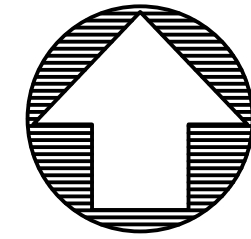


Scale: 1" = 10'

Tree Removal & Demolition

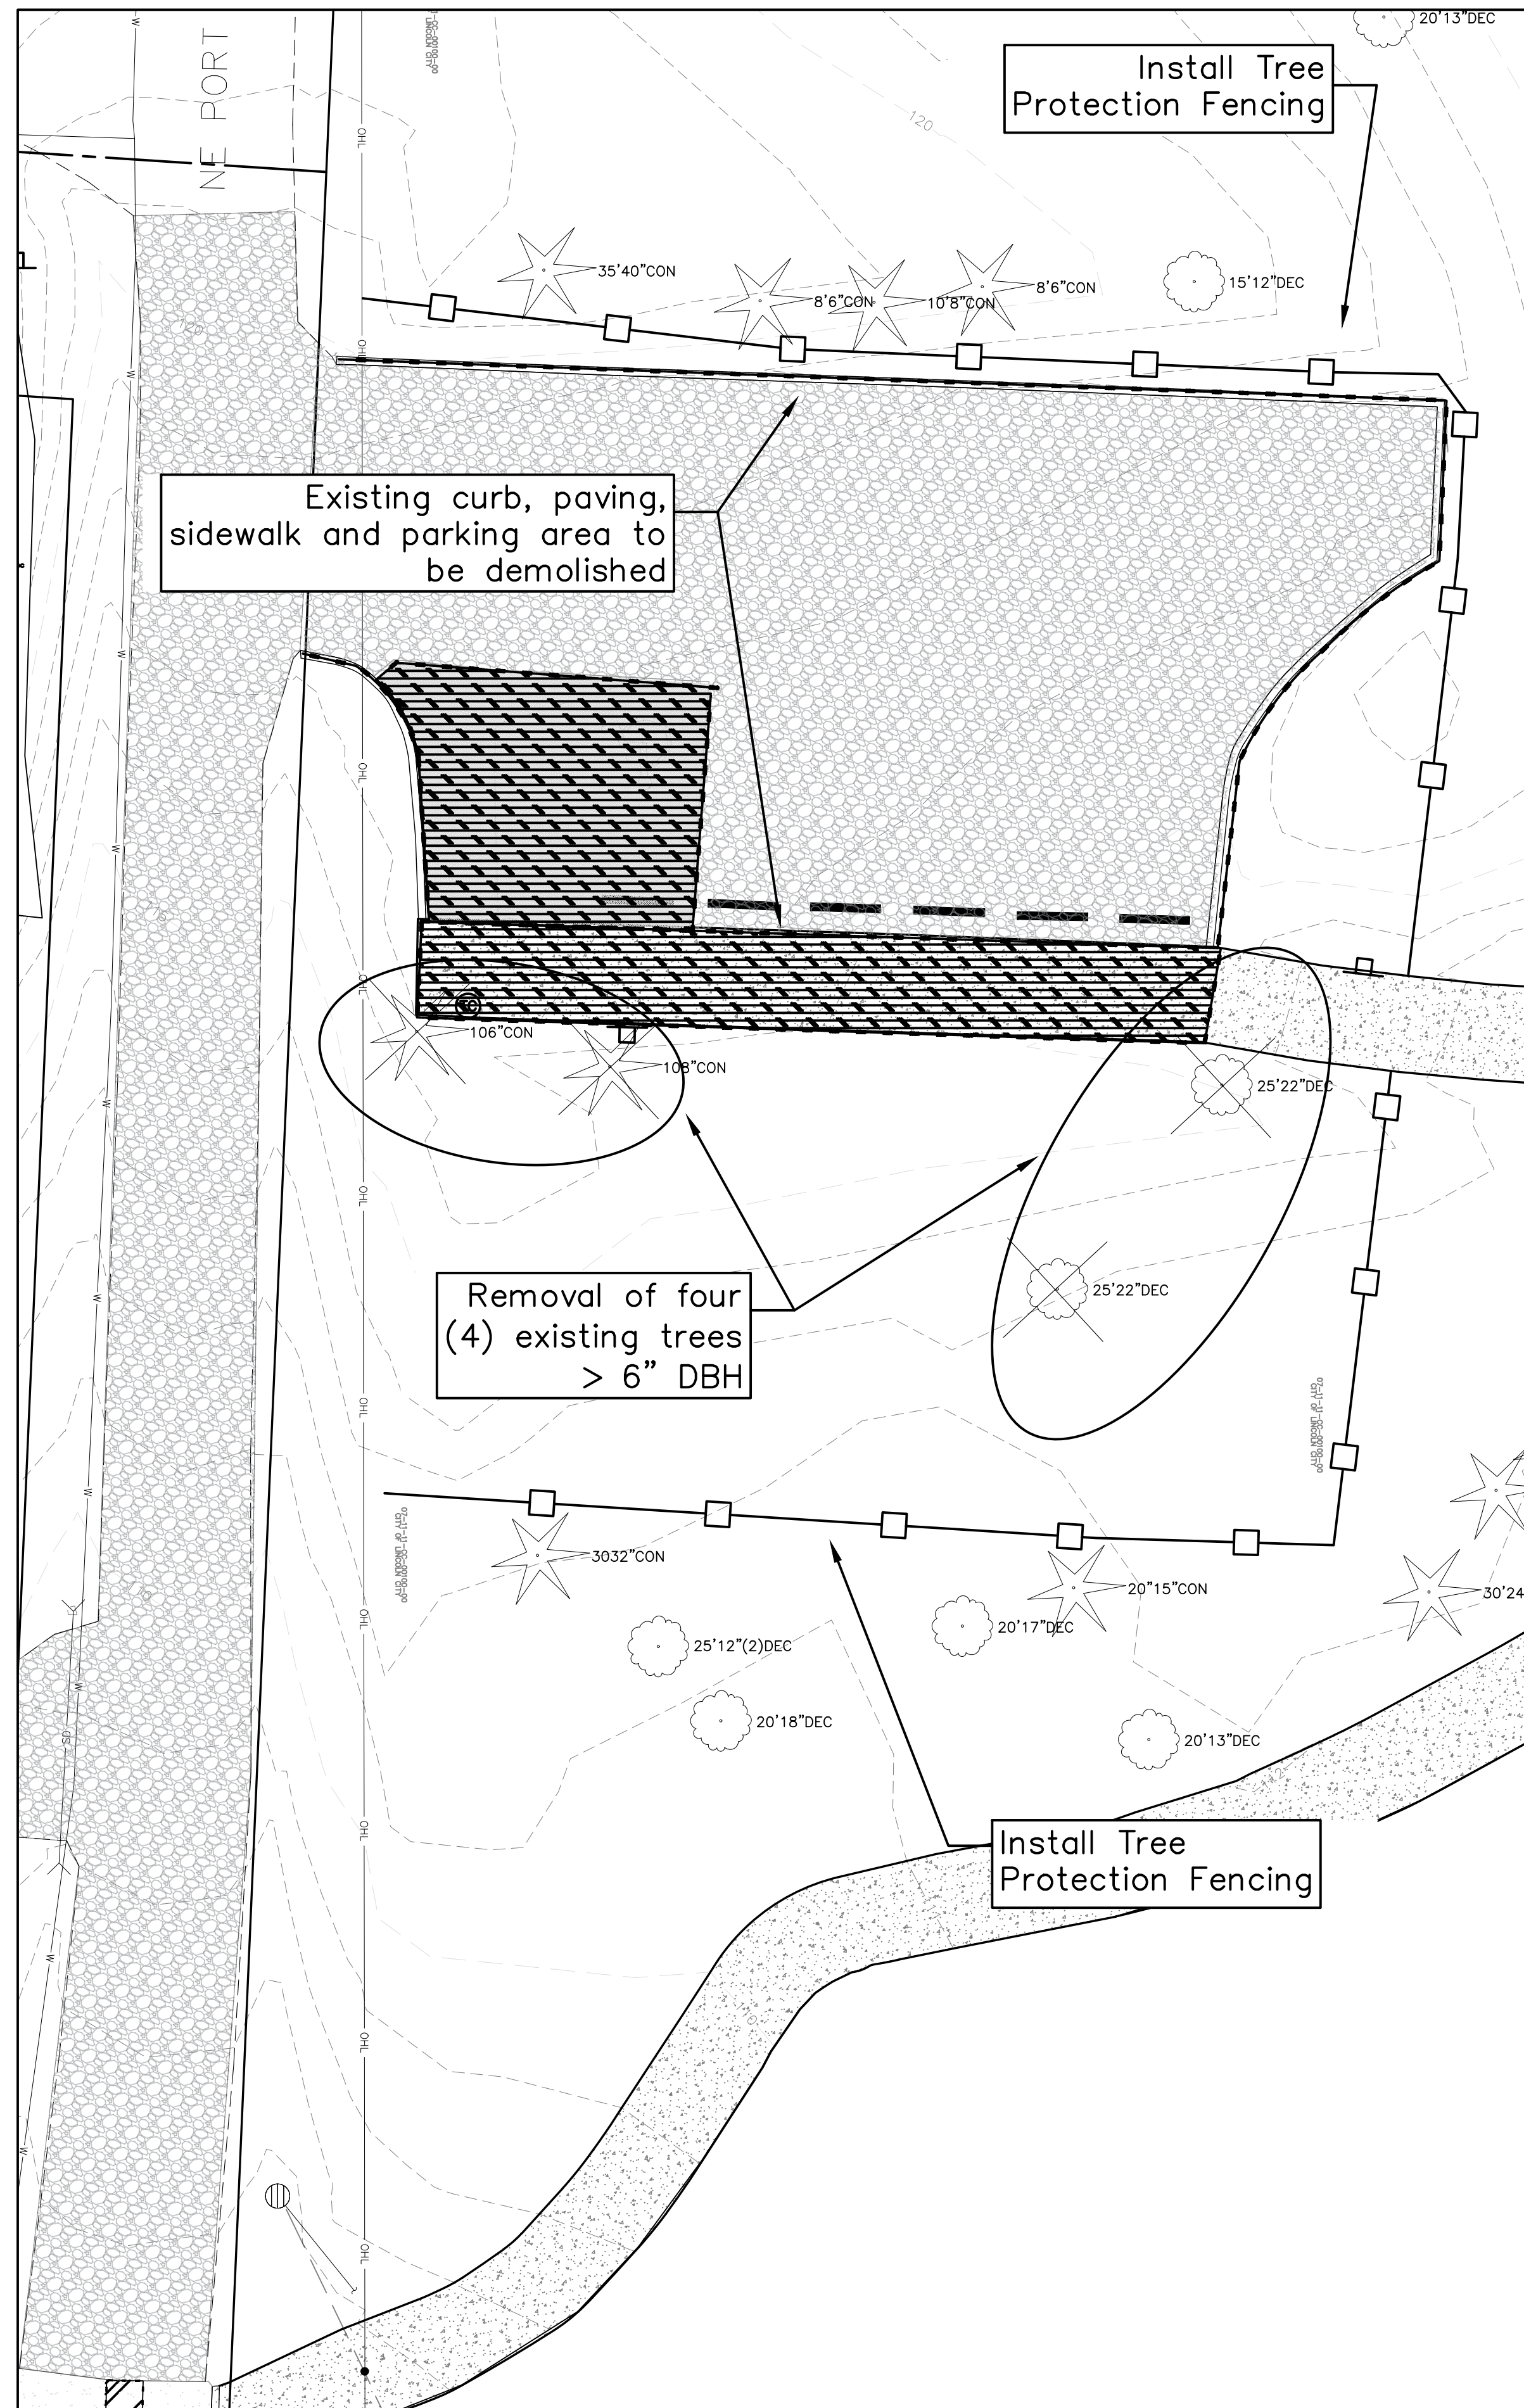

Proposed Site Development

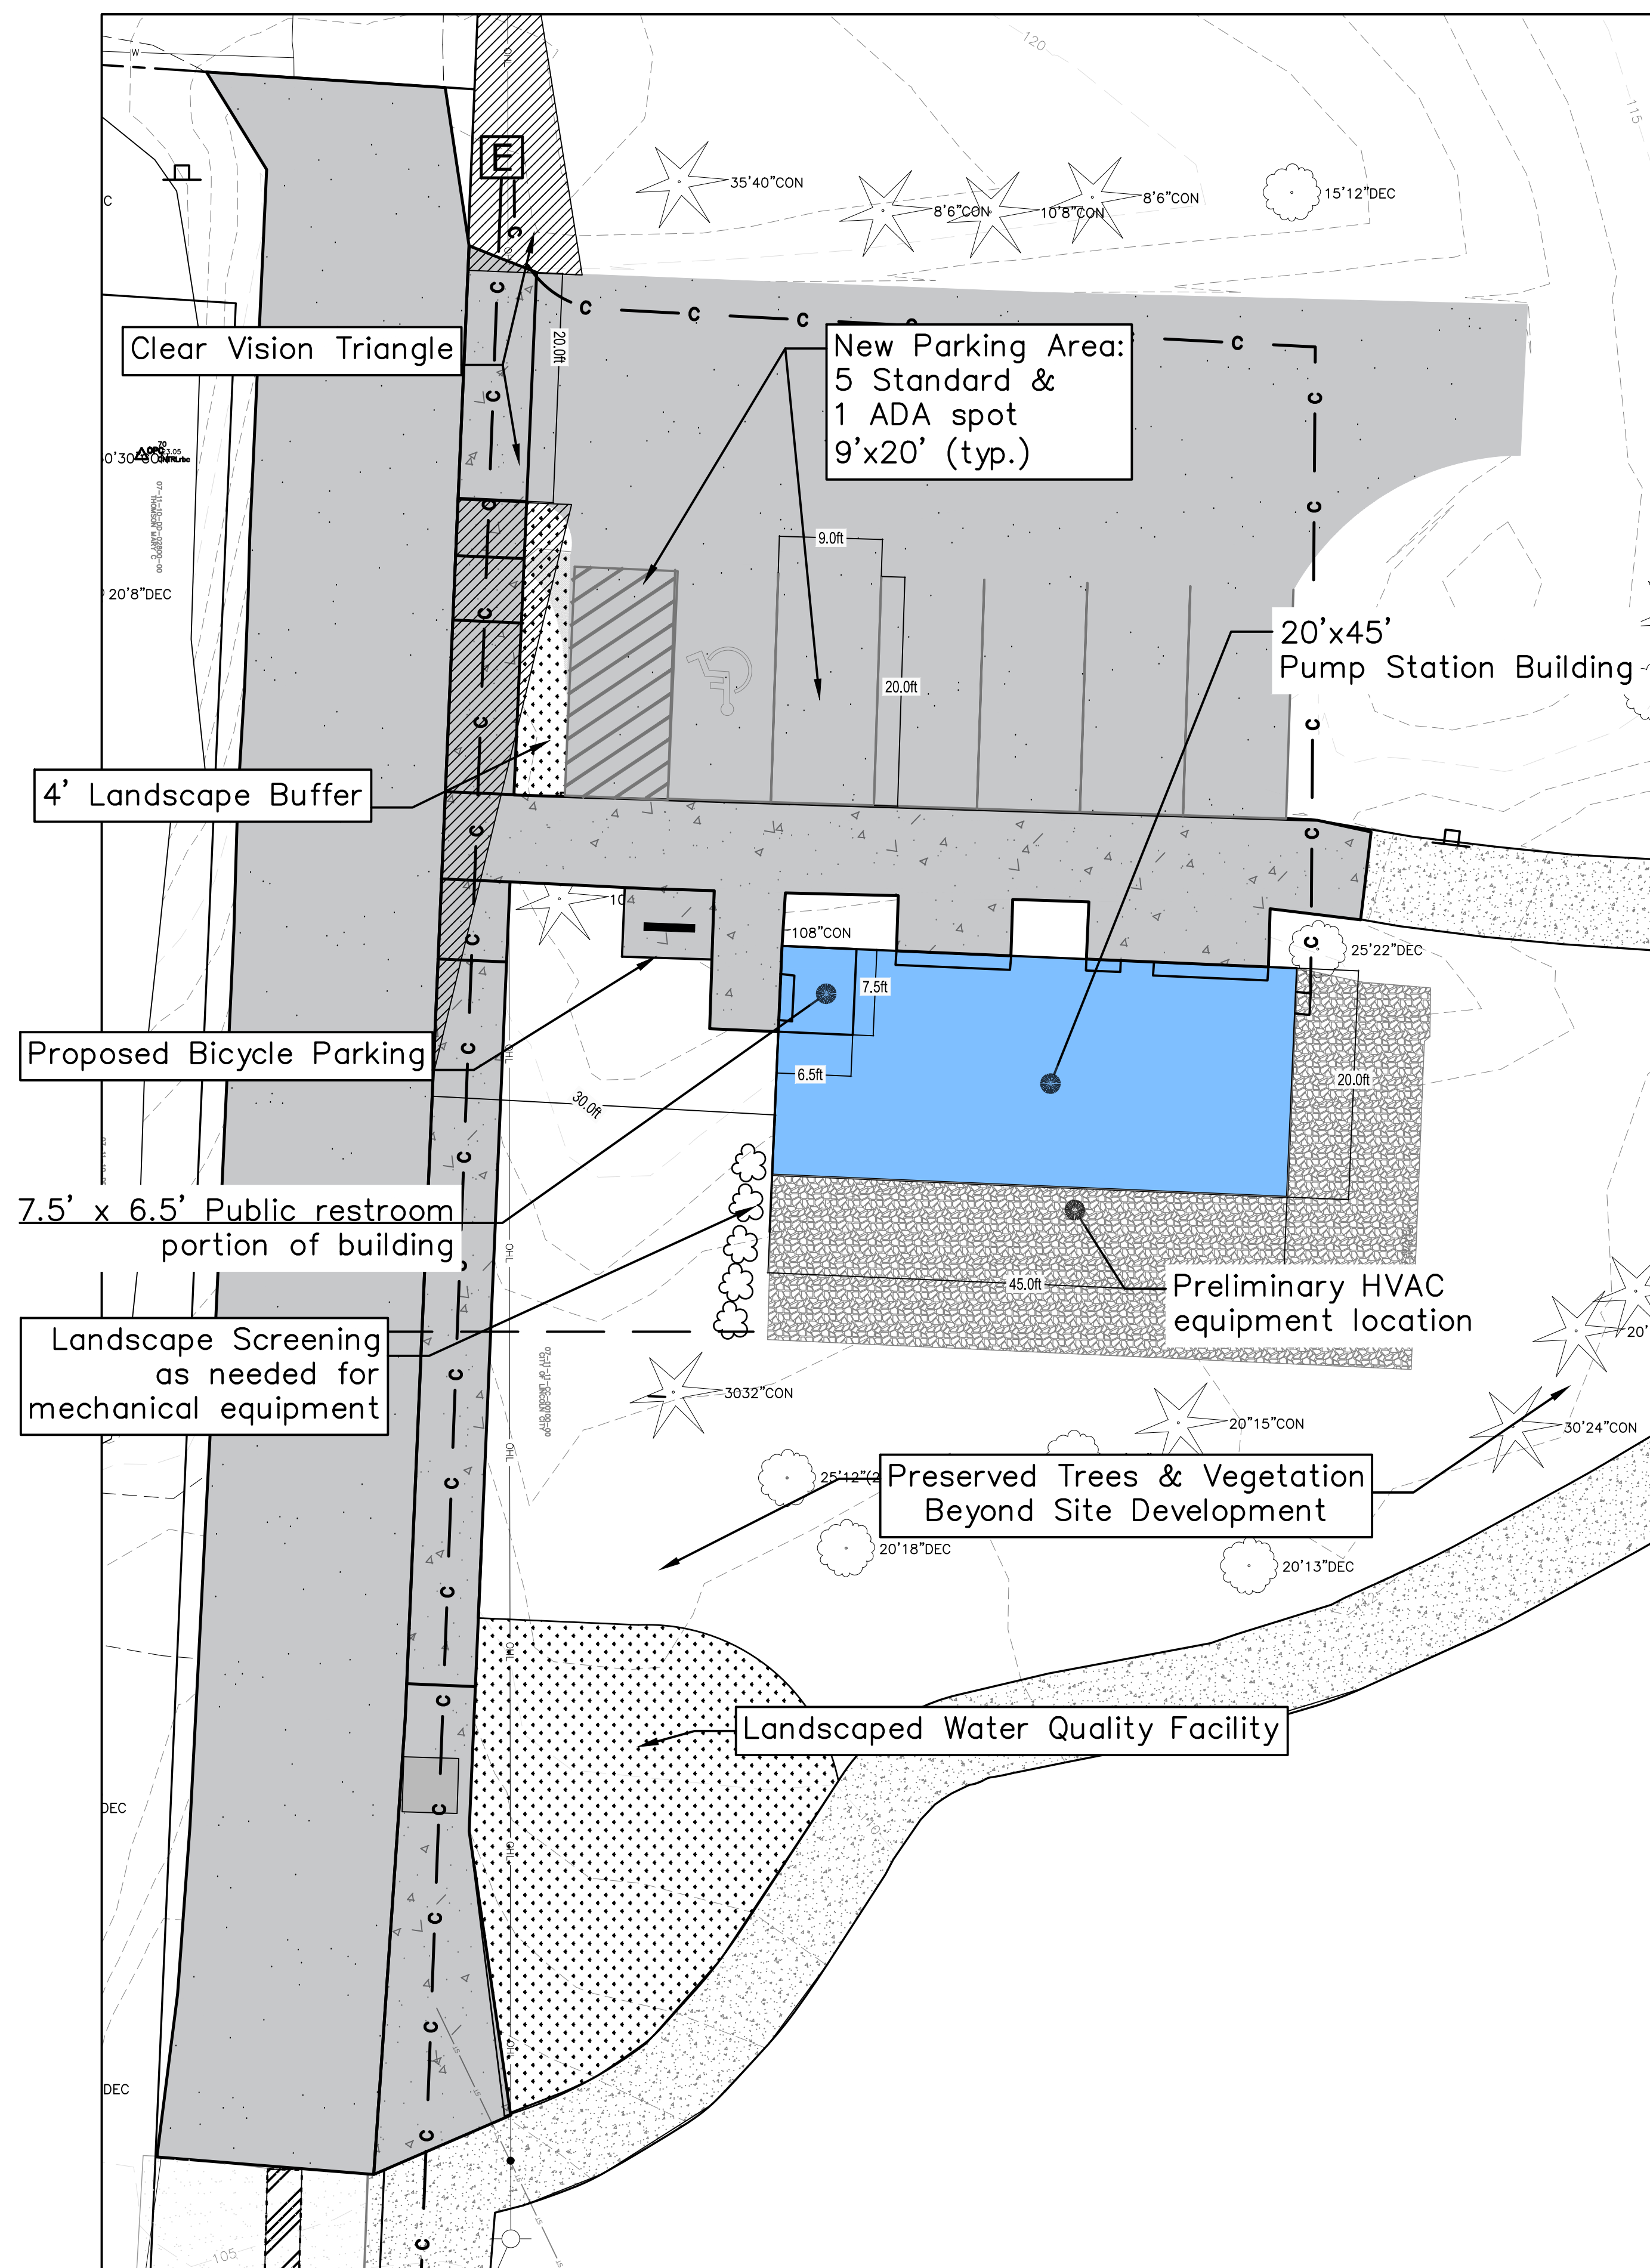

General Notes
 OWNER: LINCOLN CITY
 CITY OF LINCOLN CITY
 801 SW HIGHWAY 101
 P.O. BOX 50
 LINCOLN CITY, OREGON 97367
 CONTACT: TERRY CHAMBERLIN, P.E.
 PHONE: 541.996.1292

No.	Revision/Issue	Date

LINCOLN CITY PUBLIC WORKS
 801 S.W. HWY 101
 P.O. BOX 50
 LINCOLN CITY, OREGON 97367
 PHONE: (541) 996-2154
 FAX: (541) 994-4881
 www.lincolncity.org

Project Name and Sheet Name
Spring Lake Pump Station
Tree Removal & Parking Lot Development

DESIGNED BY: ##
 PREPARED BY: ##

Project No:	23004	Sheet No.	3 OF 5
Date	2/20/2025		
Scale	1" = 20' <small>IF LESS THAN FULL SIZE, NTS</small>		

J:\Engineering Capital Projects\23004 Spring Lake Pump Station\CAD-Spring Lake PS Concept

2/20/2025

